




JAY R. SMITH MFG. CO.®
 MEMBER OF ACORN ENGINEERING'S FAMILY OF COMPANIES
 POST OFFICE BOX 3237
 MONTGOMERY, ALABAMA 36109-0237 (USA)
 TEL: 334-277-8520 FAX: 334-272-7396 www.jrsmith.com



LOCATION

GREEN ROOF PLANTER DRAIN

OVERFLOW STANDPIPE TYPE WITH 5/8" ORIFICE

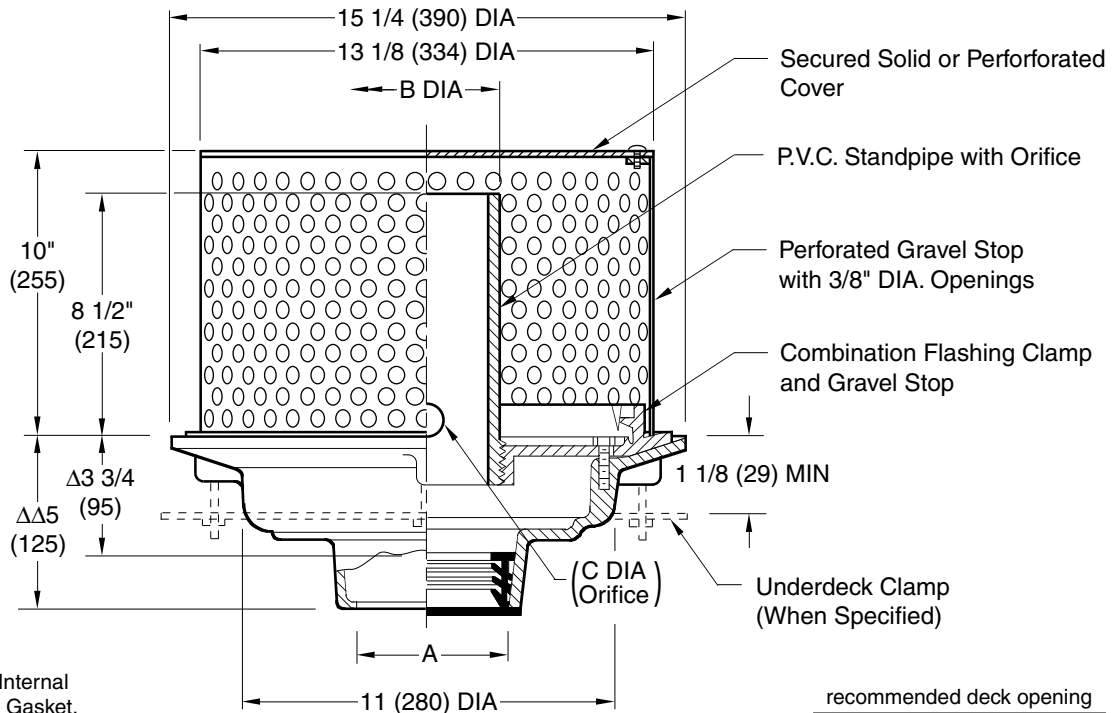

Δ This Dimension to Internal Stop of Speedi-Set Gasket.
 ΔΔ Same for Caulk, NO-HUB and Speedi-Set. 3 3/4 (95) for Threaded.

recommended deck opening	
with suffix -R	17 (430) DIA
less Suffix -R	14 (355) DIA

A (Pipe Size)	02(50)	03(75)	04(100)	05(125)	06(150)	08(200)
B (DIA)	4(100)	4(100)	4(100)	6(150)	6(150)	8(200)
C (DIA)	5/8(16)	5/8(16)	5/8(16)	1(25)	1(25)	1(25)

- Fig. 1901C CAULK OUTLET
- Fig. 1901Y NO-HUB OUTLET

REGULARLY FURNISHED:
 Duco Cast Iron Body, Flashing Clamp and Stainless Steel Perforated Gravel Stop with P.V.C. Standpipe with Orifice.

- VARIATIONS:**
- Adjustable Extension (Specify Fig. 1045)
 - Expansion Joint (Specify Fig. 1710)
 - Extension (Specify Height) -E
 - "L" Shaped Underdeck Clamp -CL
 - L Speedi-Set Service Weight
02(50), 03(75) & 04(100) sizes only
 - LXH Speedi-Set Extra Heavy
02(50), 03(75) & 04(100) sizes only
 - Secondary Flashing Clamp -C2
 - Sump Receiver -R
 - Underdeck Clamp -C
 - Vandal Proof Gravel Stop -U
 - T Threaded Outlet

- OPTIONAL MATERIALS:**
- Bronze Standpipe -BZS
 - Cast Iron Standpipe -CIS
 - Galvanized Cast Iron Body and Collar -G

NOTE: Dimensions shown in parentheses are in millimeters.

DRAWING NUMBER: S1901
 SIZE: A
 SCALE: NONE
 DATE: 11/01/05
 APPROVED BY: AM
 CHECKED BY: AM
 DRAWN BY: JJ
 FIGURE NUMBER: 1901

WE CAN ASSUME NO RESPONSIBILITY FOR USE OF SUPERSEDED OR VOID DATA

DIMENSIONS ARE SUBJECT TO MANUFACTURERS TOLERANCE AND CHANGE WITHOUT NOTICE

C	10/27/10	Revised Drawing	RN	AM
B	03/25/10	Removed SQ note, Added Text	JJ	TK
A	10/30/09	Renamed as 1901	JJ	TK
REV.	DATE	DESCRIPTION	BY	CKD. BY

WEIGHT POUNDS	VOLUME CUBIC FEET
---------------	-------------------

FIGURE NUMBER
1901


FIGURE NUMBER	1901BS	DRAWN BY: JJ	CHECKED BY: JM	APPROVED BY: JM	DATE: 08/09/07	SCALE: NONE	SIZE A	DRAWING NUMBER S1901BS	A
---------------	---------------	-----------------	-------------------	--------------------	-------------------	----------------	-----------	---------------------------	---

DIMENSIONS ARE SUBJECT TO MANUFACTURERS TOLERANCE AND CHANGE WITHOUT NOTICE

WE CAN ASSUME NO RESPONSIBILITY FOR USE OF SUPERSEDED OR VOID DATA

SPECIAL PURPOSE GREEN ROOF DRAINS

INSTALLATION ILLUSTRATION

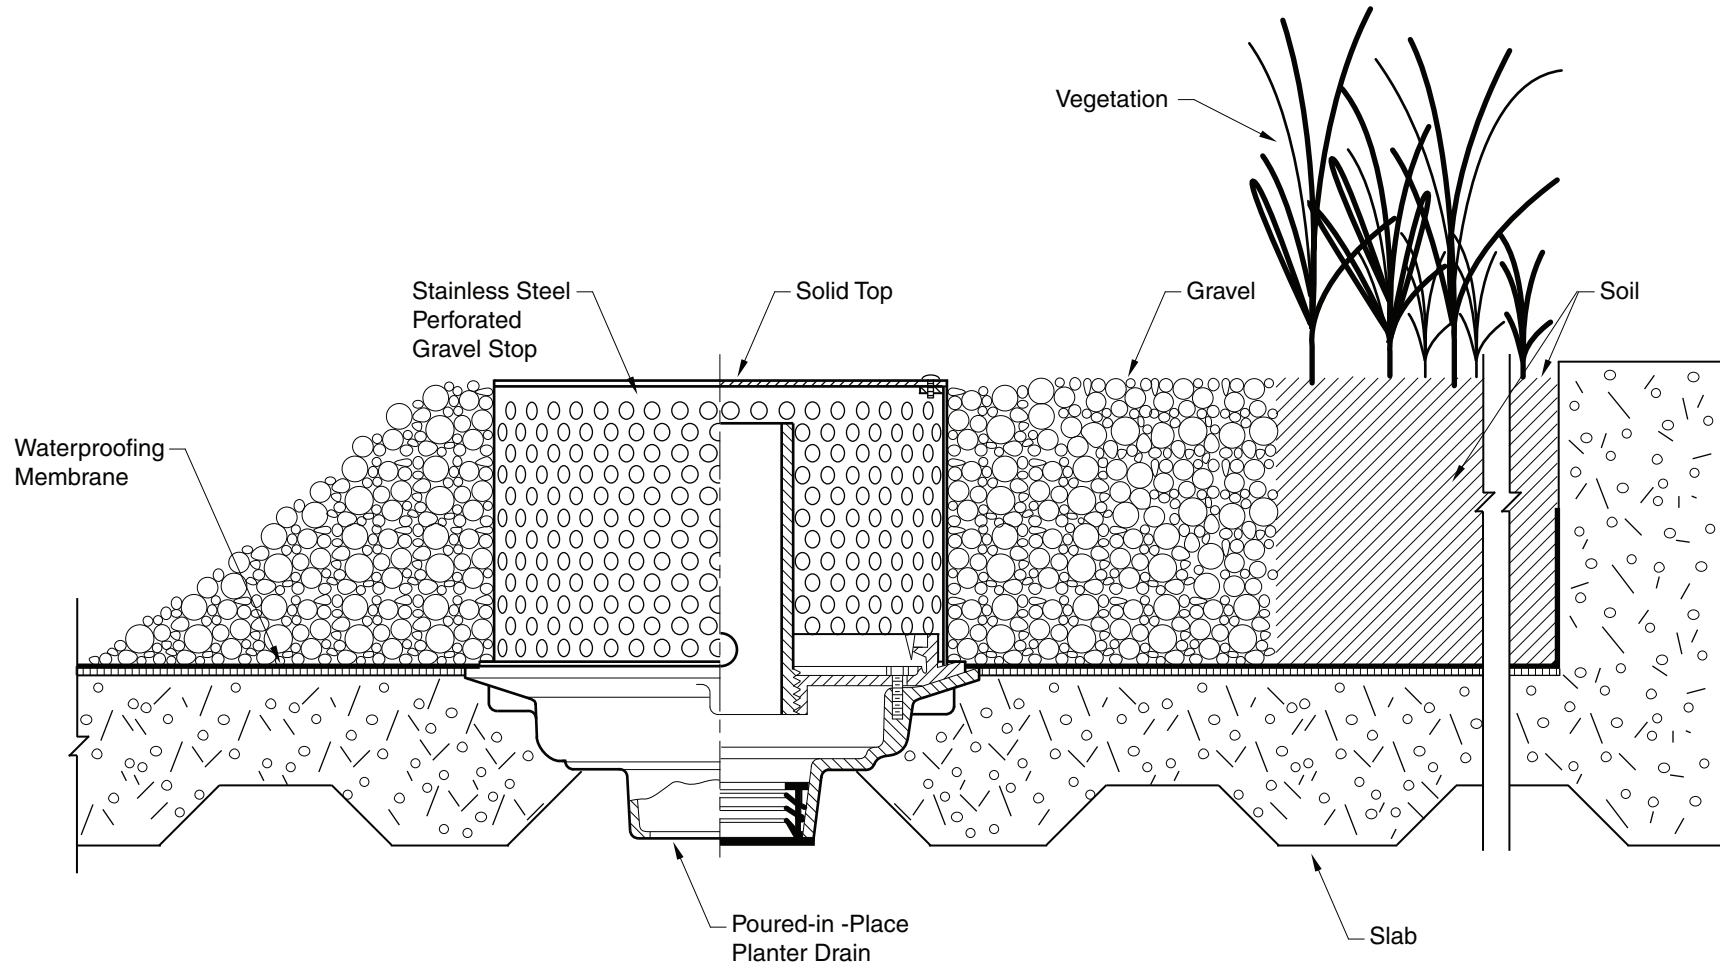

SPECIAL PURPOSE ROOFTOP PLANTER DRAIN WITH OVERFLOW PIPE

SMITH® JAY R. SMITH MFG. CO.®
 MEMBER OF ACORN ENGINEERING'S FAMILY OF COMPANIES
 POST OFFICE BOX 3237
 MONTGOMERY, ALABAMA 36109-0237 (USA)
 TEL: 334-277-8520 FAX: 334-272-7396 www.jrsmith.com



MEMBER OF:

REV.	DATE	DESCRIPTION	BY	CKD. BY
A	07/10/08	Added Membrane & Vegetation	JJ	JM